


AAHF 2018 as of 01/31/2018

Dimension	Size	Qty	SqFt
10'x10'	100	118	11,800
10'x20'	200	9	1,800
Totals:		127	13,600

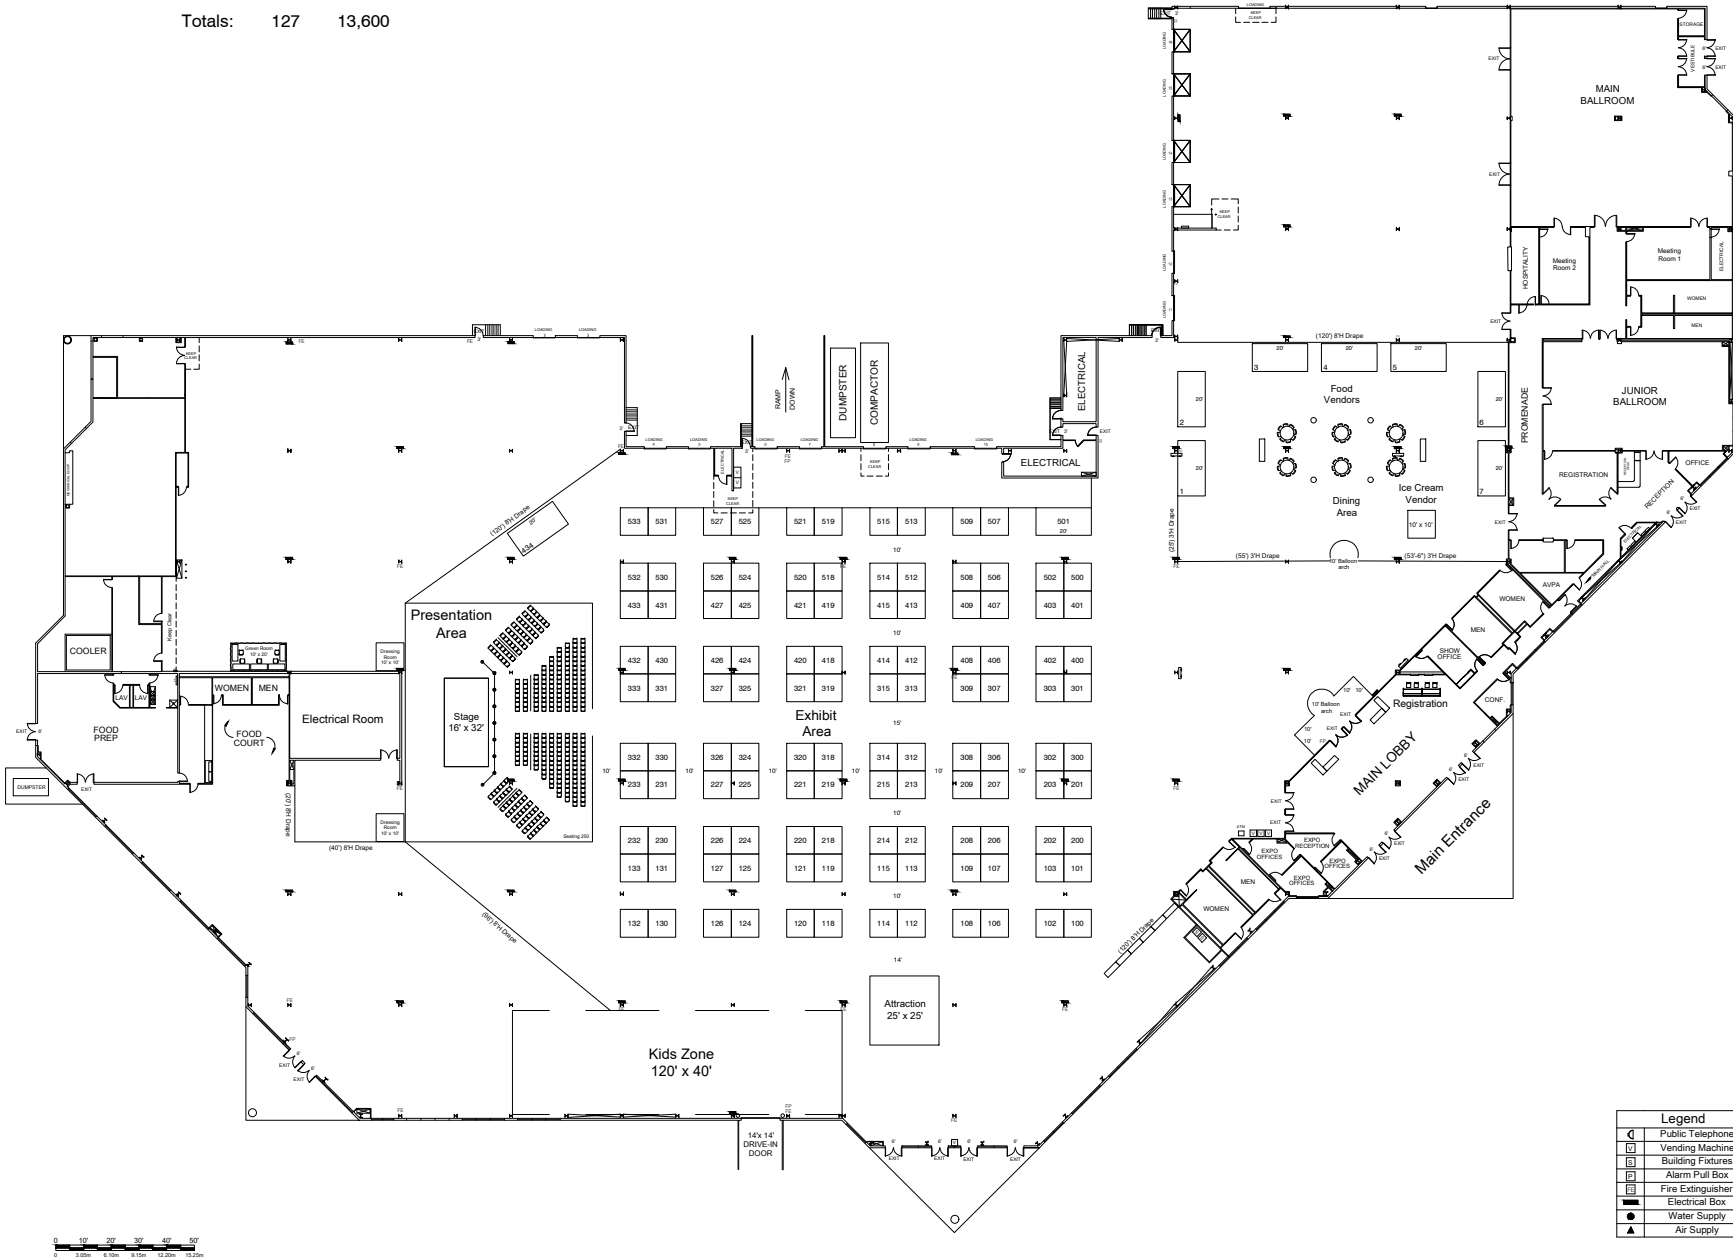

Legend	
	Public Telephone
	Vending Machine
	Building Fixtures
	Alarm Pull Box
	Fire Extinguisher
	Electrical Box
	Water Supply
	Air Supply

Asian American Heritage Festival

May 2018
NJC&EC - Raritan Center - Edison, NJ

REVISION DATE: 01/31/2018

DRAWN BY: T. Harris

2320 Linwood Avenue
Suite 4A
Fort Lee, NJ 07024
Tel: 201.884.8347
Fax: 201.731.5357



Disclaimer: Every effort has been made to ensure the accuracy of all information contained on this floor plan. However, no warranty, either expressed or implied, can be made with respect to this floor plan. If the location of building columns, utilities or other features are not shown on this floor plan, it is the responsibility of the exhibitor to physically inspect the facility to verify all dimensions and locations.