 



AAHF 2017 as of 03/28/2017

Dimension	Size	Qty	SqFt
10'x10'	100	120	12,000
10'x20'	200	5	1,000
Totals:		125	13,000

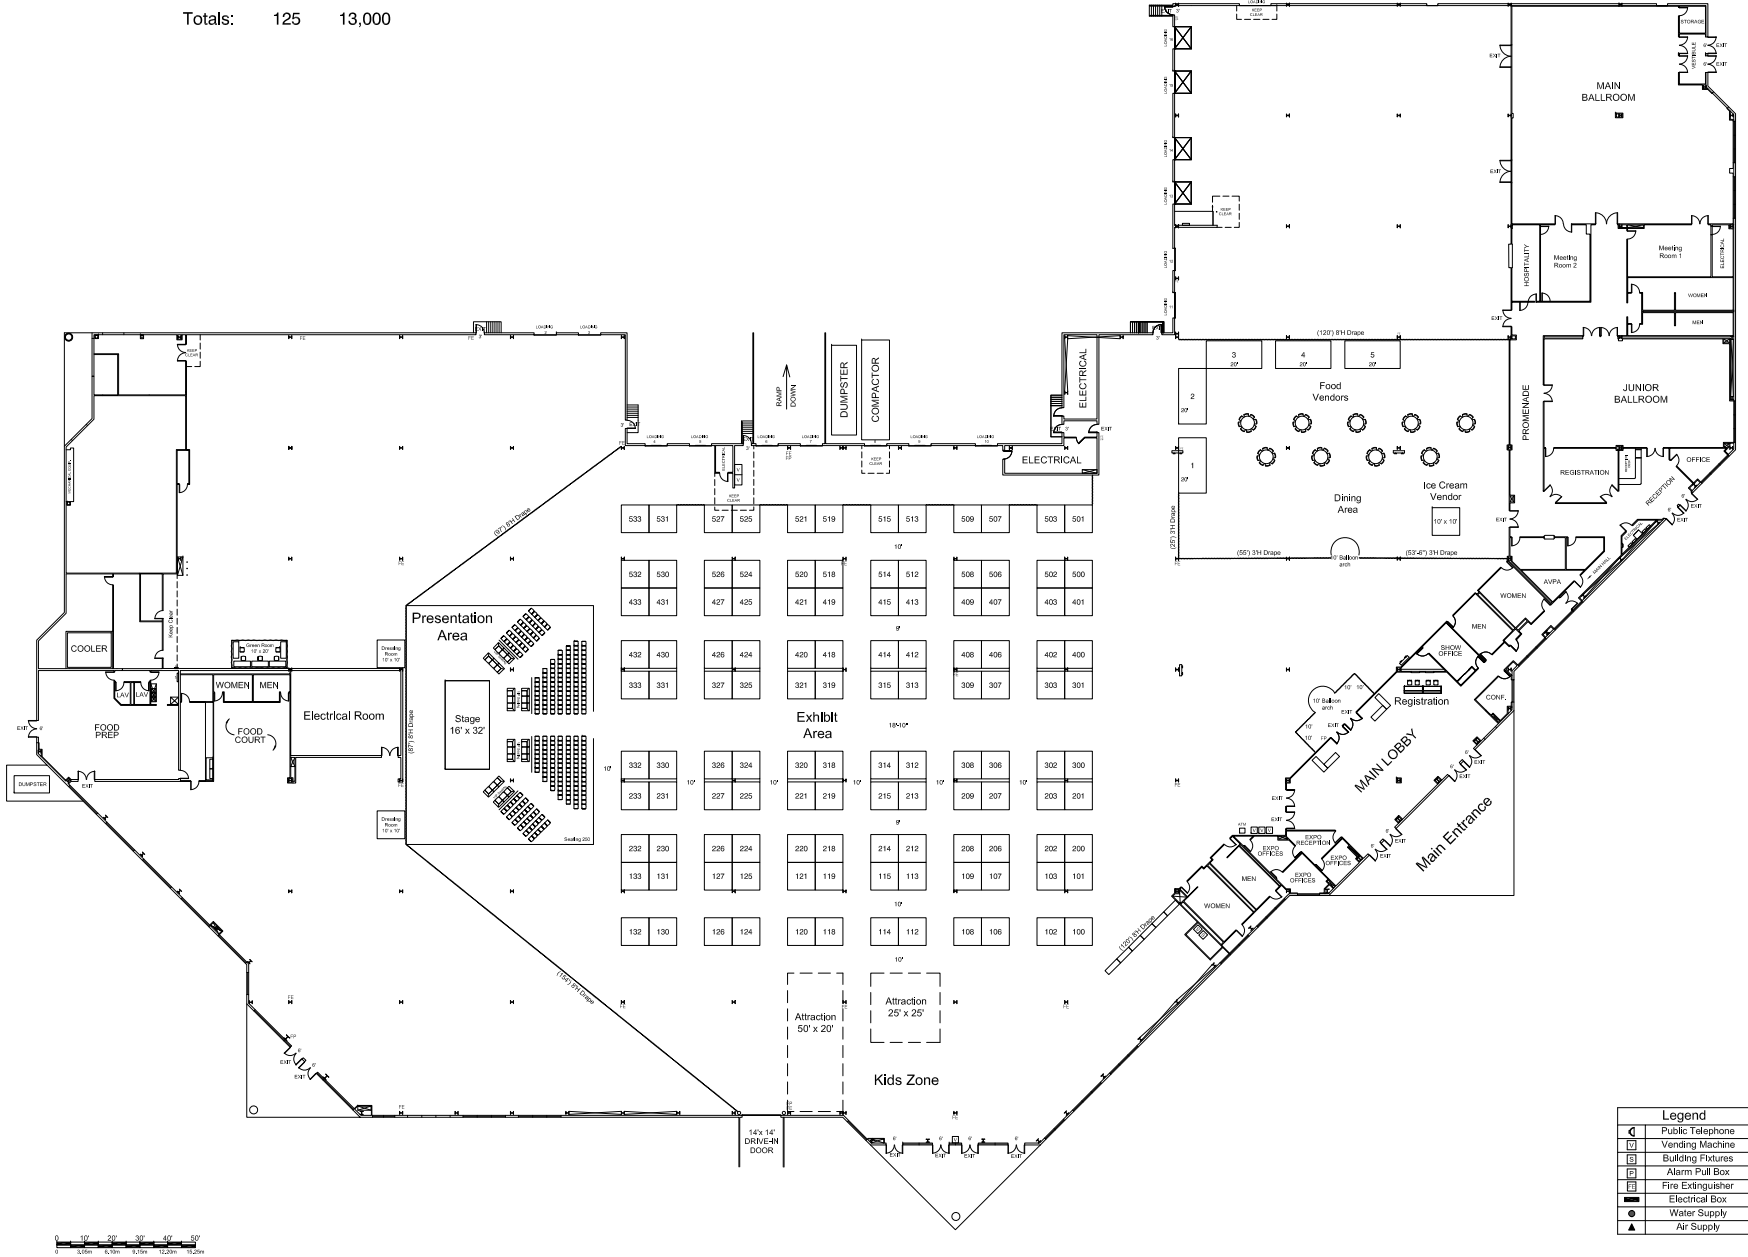

Legend	
	Public Telephone
	Vending Machines
	Building Fixtures
	Alarm Pull Box
	Fire Extinguisher
	Electrical Box
	Water Supply
	Air Supply

Asian American Heritage Festival Opt2

May 2017

NJC&EC - Raritan Center - Edison, NJ

DRAWN BY: T. Harris

REVISION DATE: 03/28/2017

52 Forest Avenue
 Paramus, NJ 07652
 Tel: 201.884.5347
 Fax: 201.731.5357



Disclaimer: Every effort has been made to ensure the accuracy of all information contained on this floor plan. However, no warranties, either expressed or implied, are made with respect to this floor plan or the location of building columns, utilities or other features. The contractor is solely responsible for any discrepancies or omissions of an exhibit, its size or placement, or its location, or for any other information not depicted.