


AAHF 2019 as of 04/25/2019

Dimension	Size	Qty	SqFt
10'x10'	100	118	11,800
10'x20'	200	3	600
Totals:		121	12,400

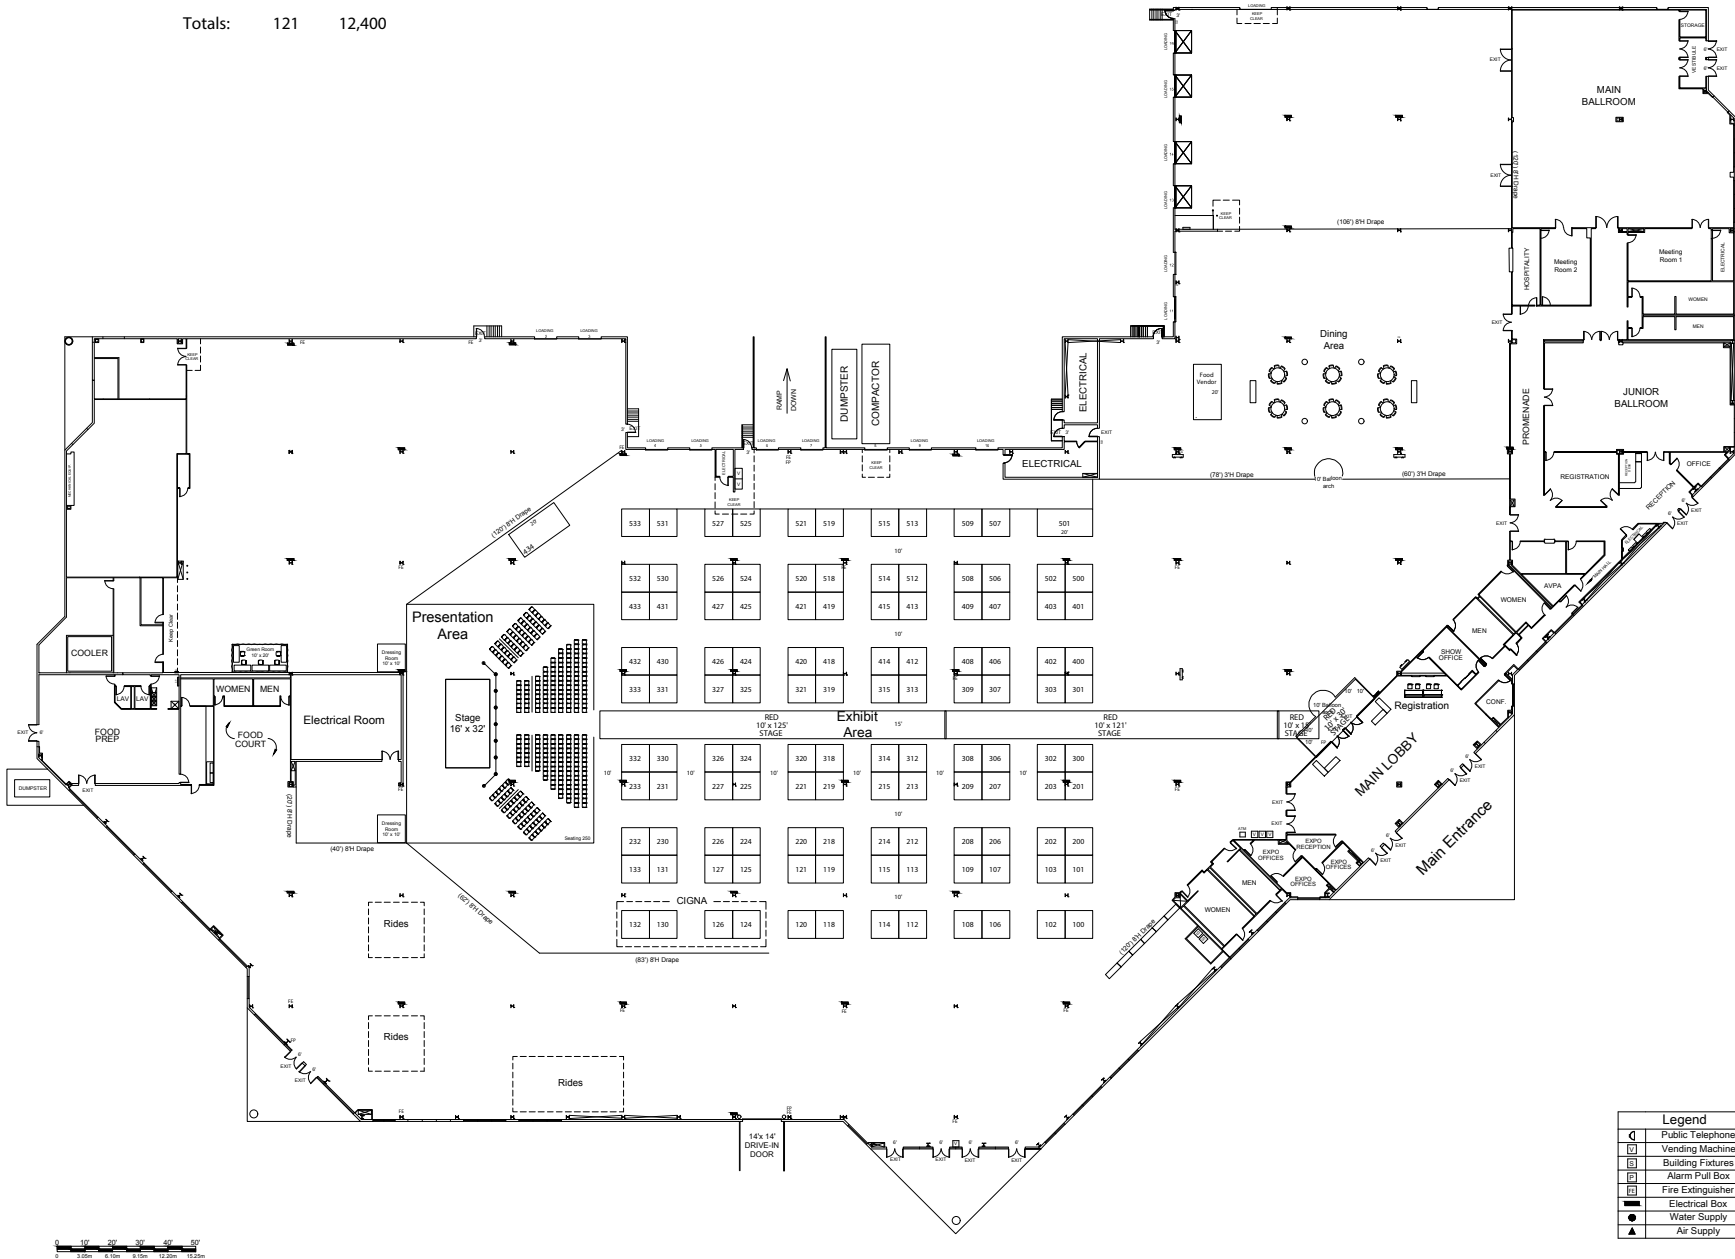

Legend	
	Public Telephone
	Vending Machine
	Building Fixtures
	Alarm Pull Box
	Fire Extinguisher
	Electrical Box
	Water Supply
	Air Supply

Asian American Heritage Festival

May 2019

NJC&EC - Raritan Center - Edison, NJ

DRAWN BY: T. Harris

REVISION DATE: 04/25/2019

2320 Linwood Avenue
 Suite 4A
 Fort Lee, NJ 07024
 Tel: 201.884.8347
 Fax: 201.731.5357



Disclaimer: Every effort has been made to ensure the accuracy of all information contained on this floor plan. However, the user of this floor plan is advised that the information is provided for informational purposes only and is not intended to be a contract. The user of this floor plan is advised that the information is provided for informational purposes only and is not intended to be a contract. The user of this floor plan is advised that the information is provided for informational purposes only and is not intended to be a contract. The user of this floor plan is advised that the information is provided for informational purposes only and is not intended to be a contract.